
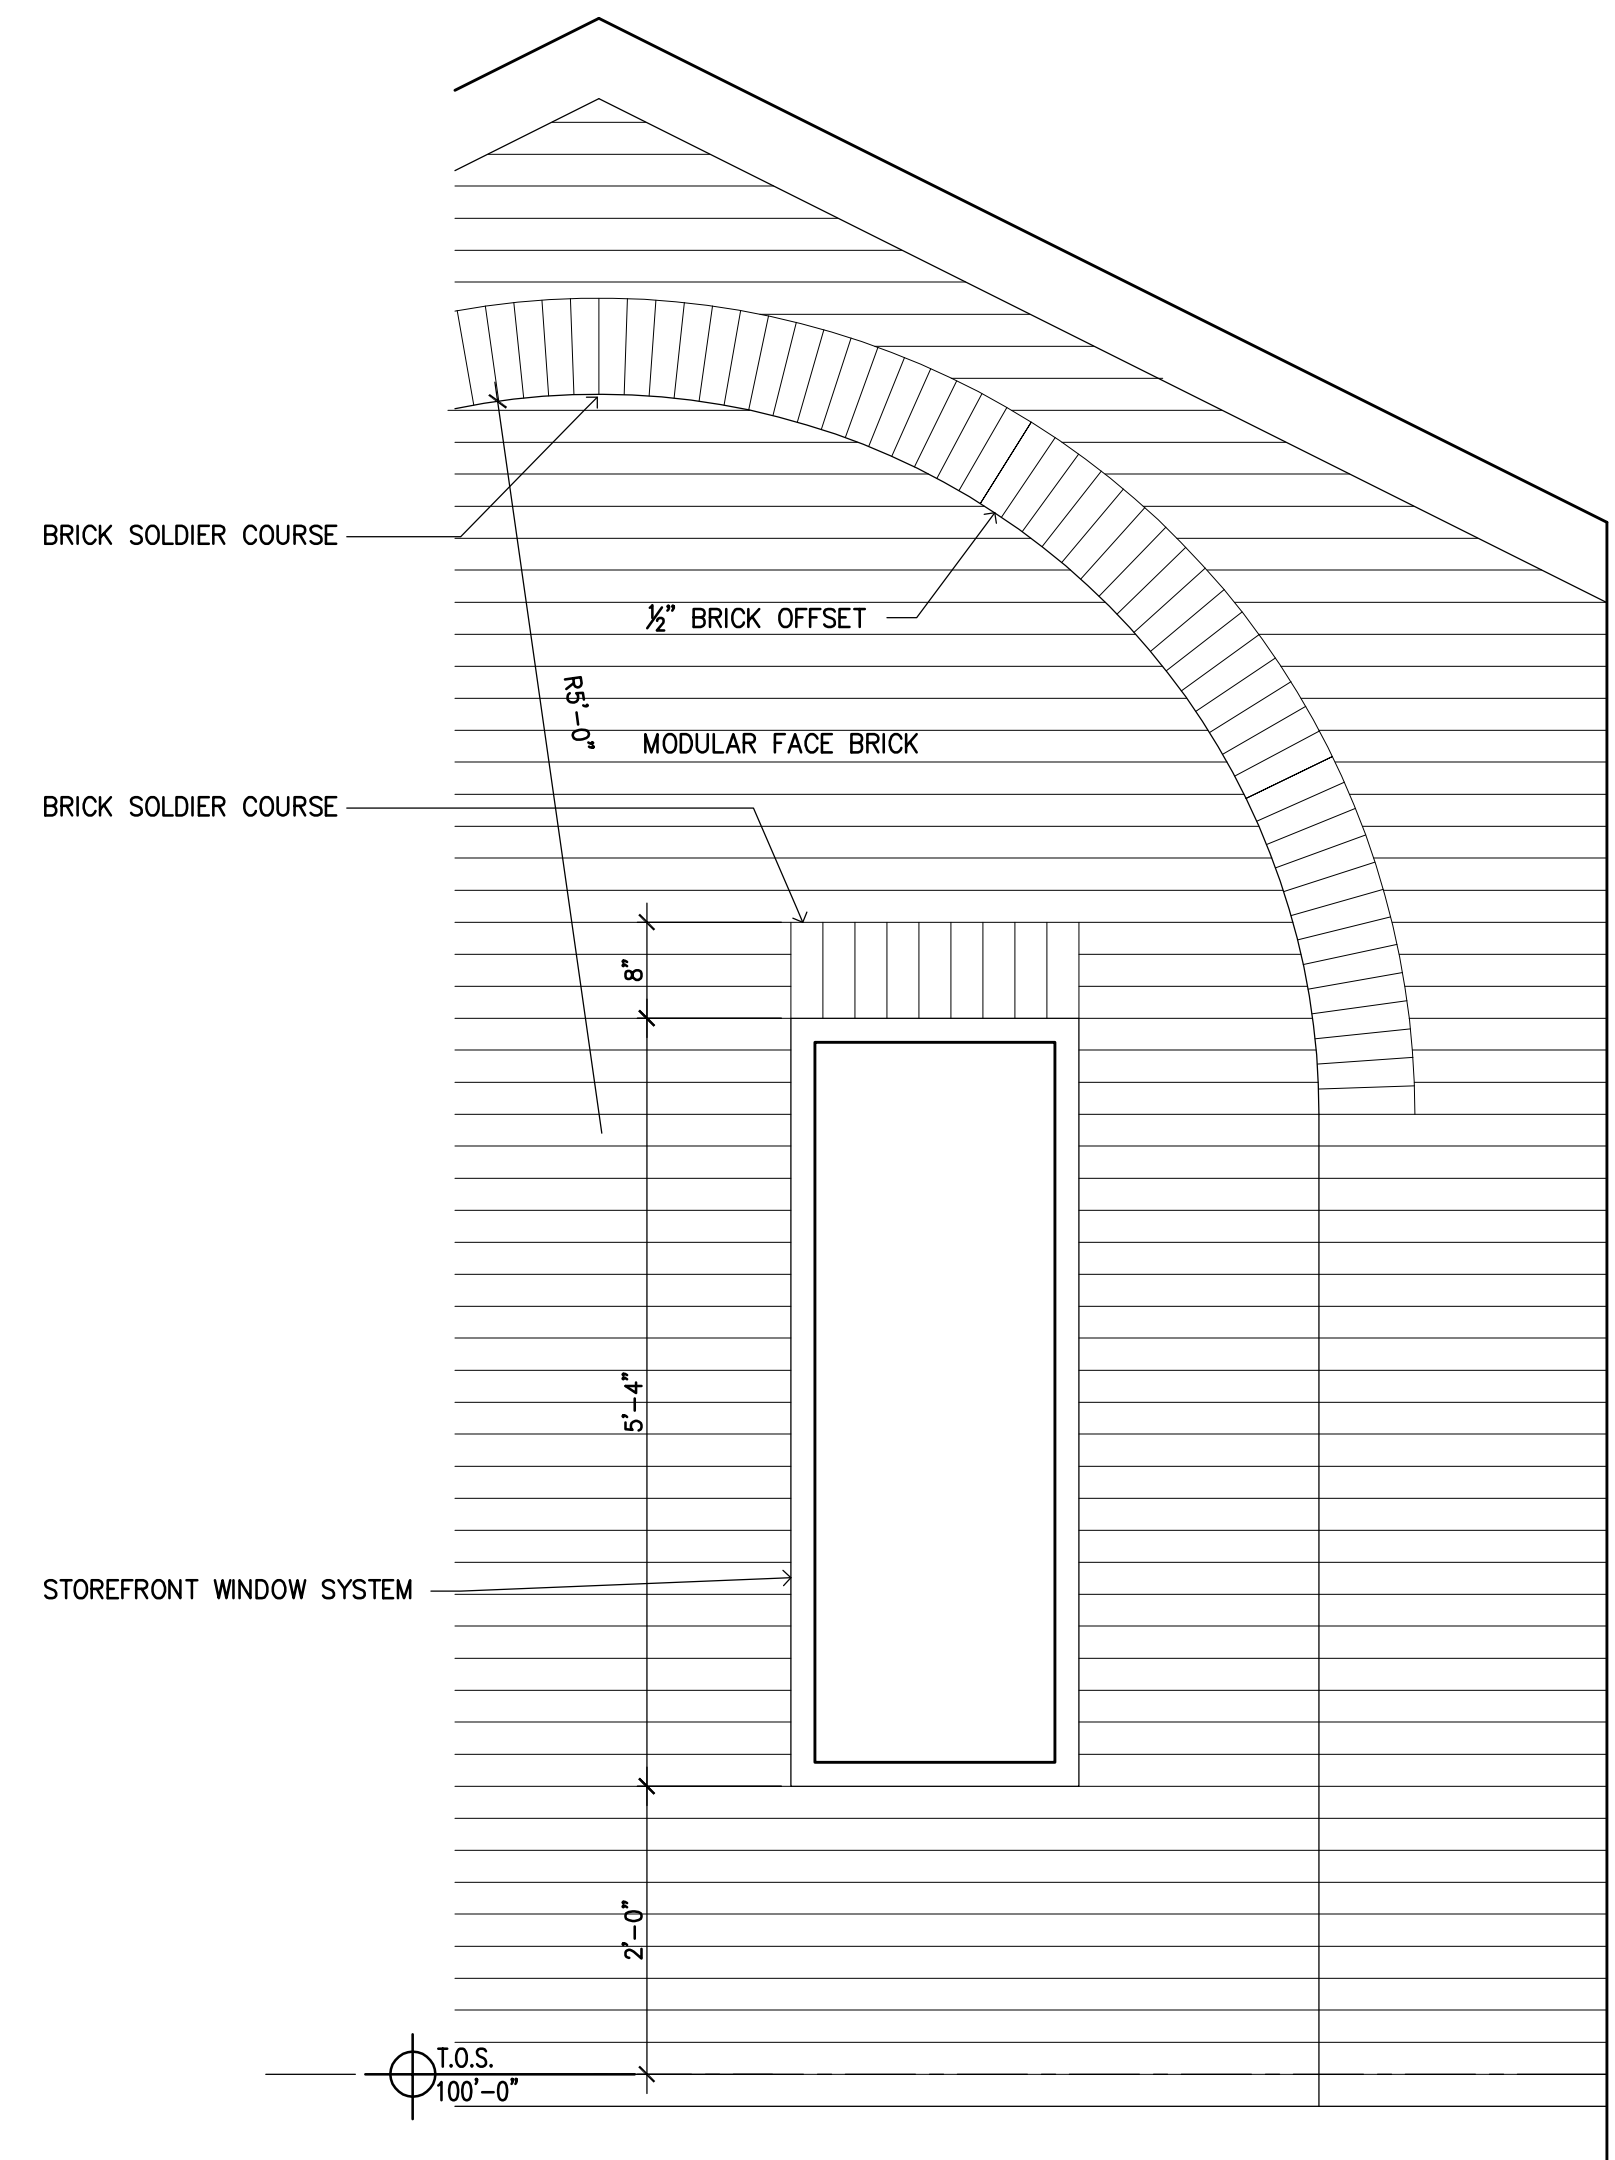


PROVIDE WR GYP BD AT ALL PARTITIONS WITH PLUMBING FIXTURES OR SUBJECT TO WATER SPLASH (I.E. TUB & SHOWER SURROUNDS)

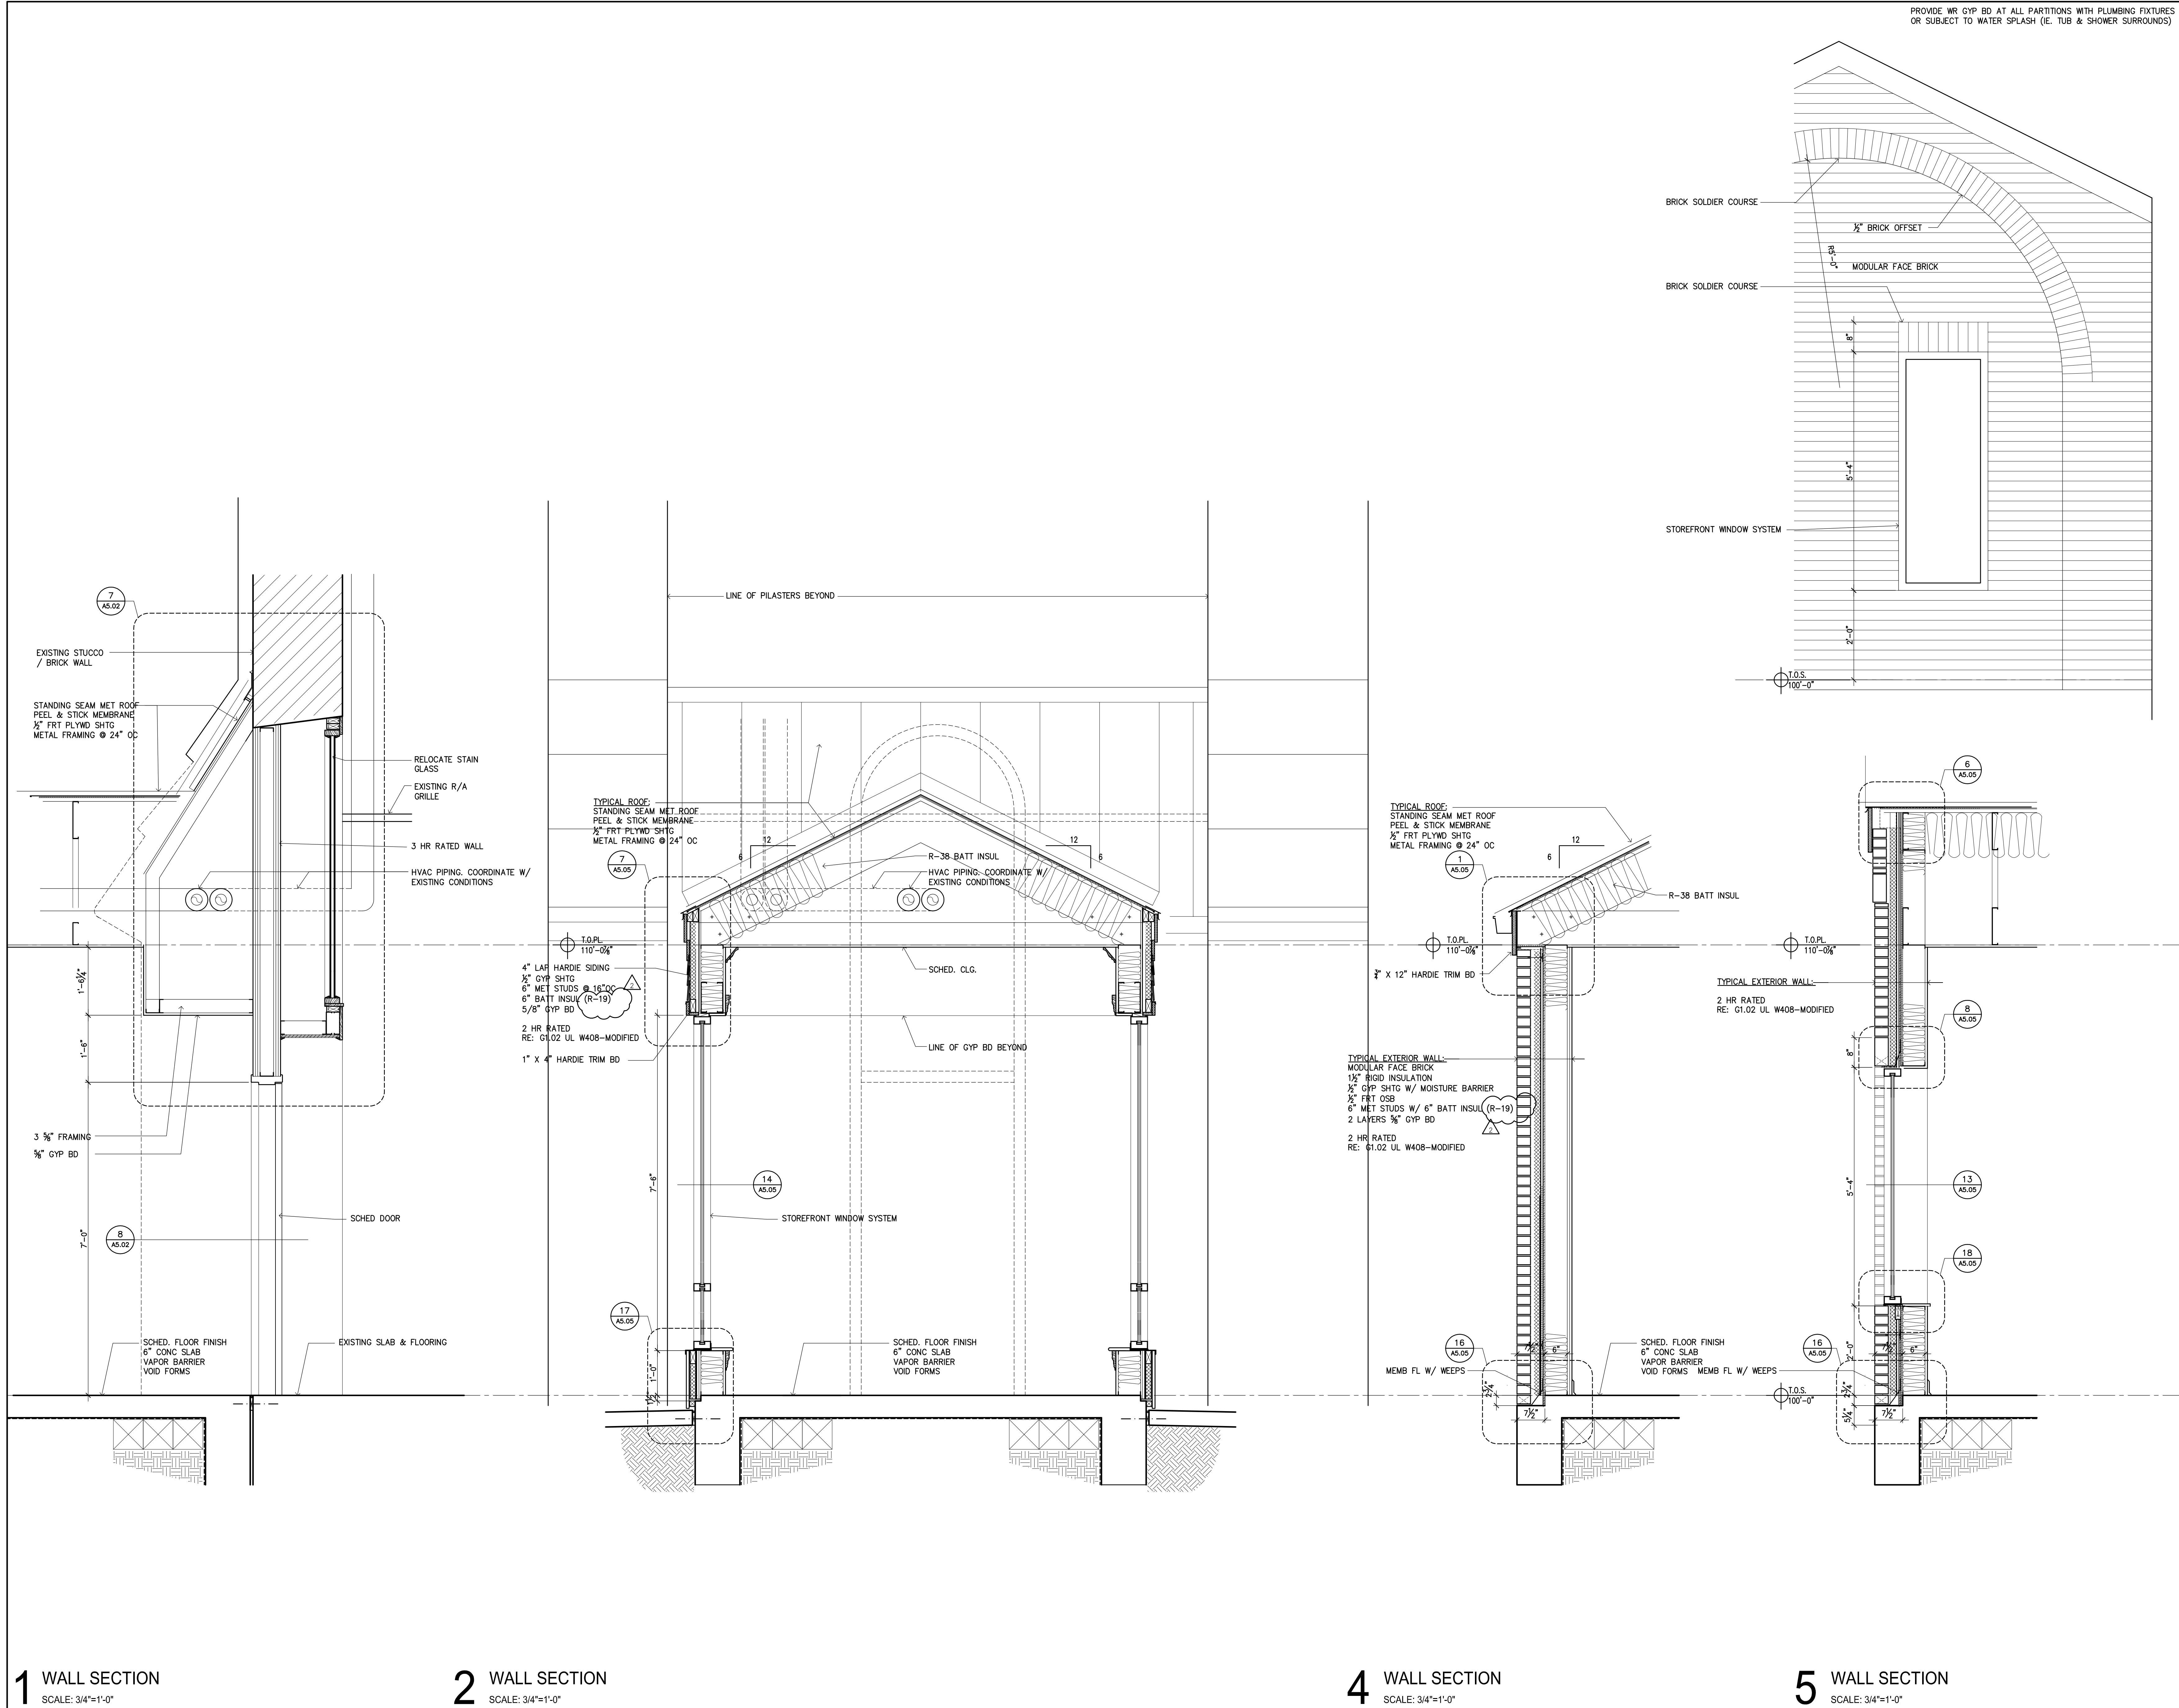

**ISSUES**

NO.	DATE	DESCRIPTION
1/27/2017	50% CD REVIEW	
3/6/2017	ISSUED FOR PERMIT	
6/30/2017	100% CD REVIEW	
7/14/2017	ISSUED FOR PERMIT	

**REVISIONS**

NO.	DATE	DESCRIPTION
9/15/2017	PERMIT COMMENTS	
10/20/2017	PERMIT COMMENTS	



**ANNUNCIATION  
CATHOLIC CHURCH  
FOLEY HOUSE RENOVATION  
RECTORY AND RESTROOM  
ADDITION**

**WALL SECTIONS  
RESTROOMS**

**A3.23**

**1 WALL SECTION**  
SCALE: 3/4"=1'-0"

**2 WALL SECTION**  
SCALE: 3/4"=1'-0"

**4 WALL SECTION**  
SCALE: 3/4"=1'-0"

**5 WALL SECTION**  
SCALE: 3/4"=1'-0"