


PROVIDE MR GYP BD AT ALL PARTITIONS WITH PLUMBING FIXTURES OR SUBJECT TO WATER SPLASH (IE. TUB & SHOWER SURROUNDS)

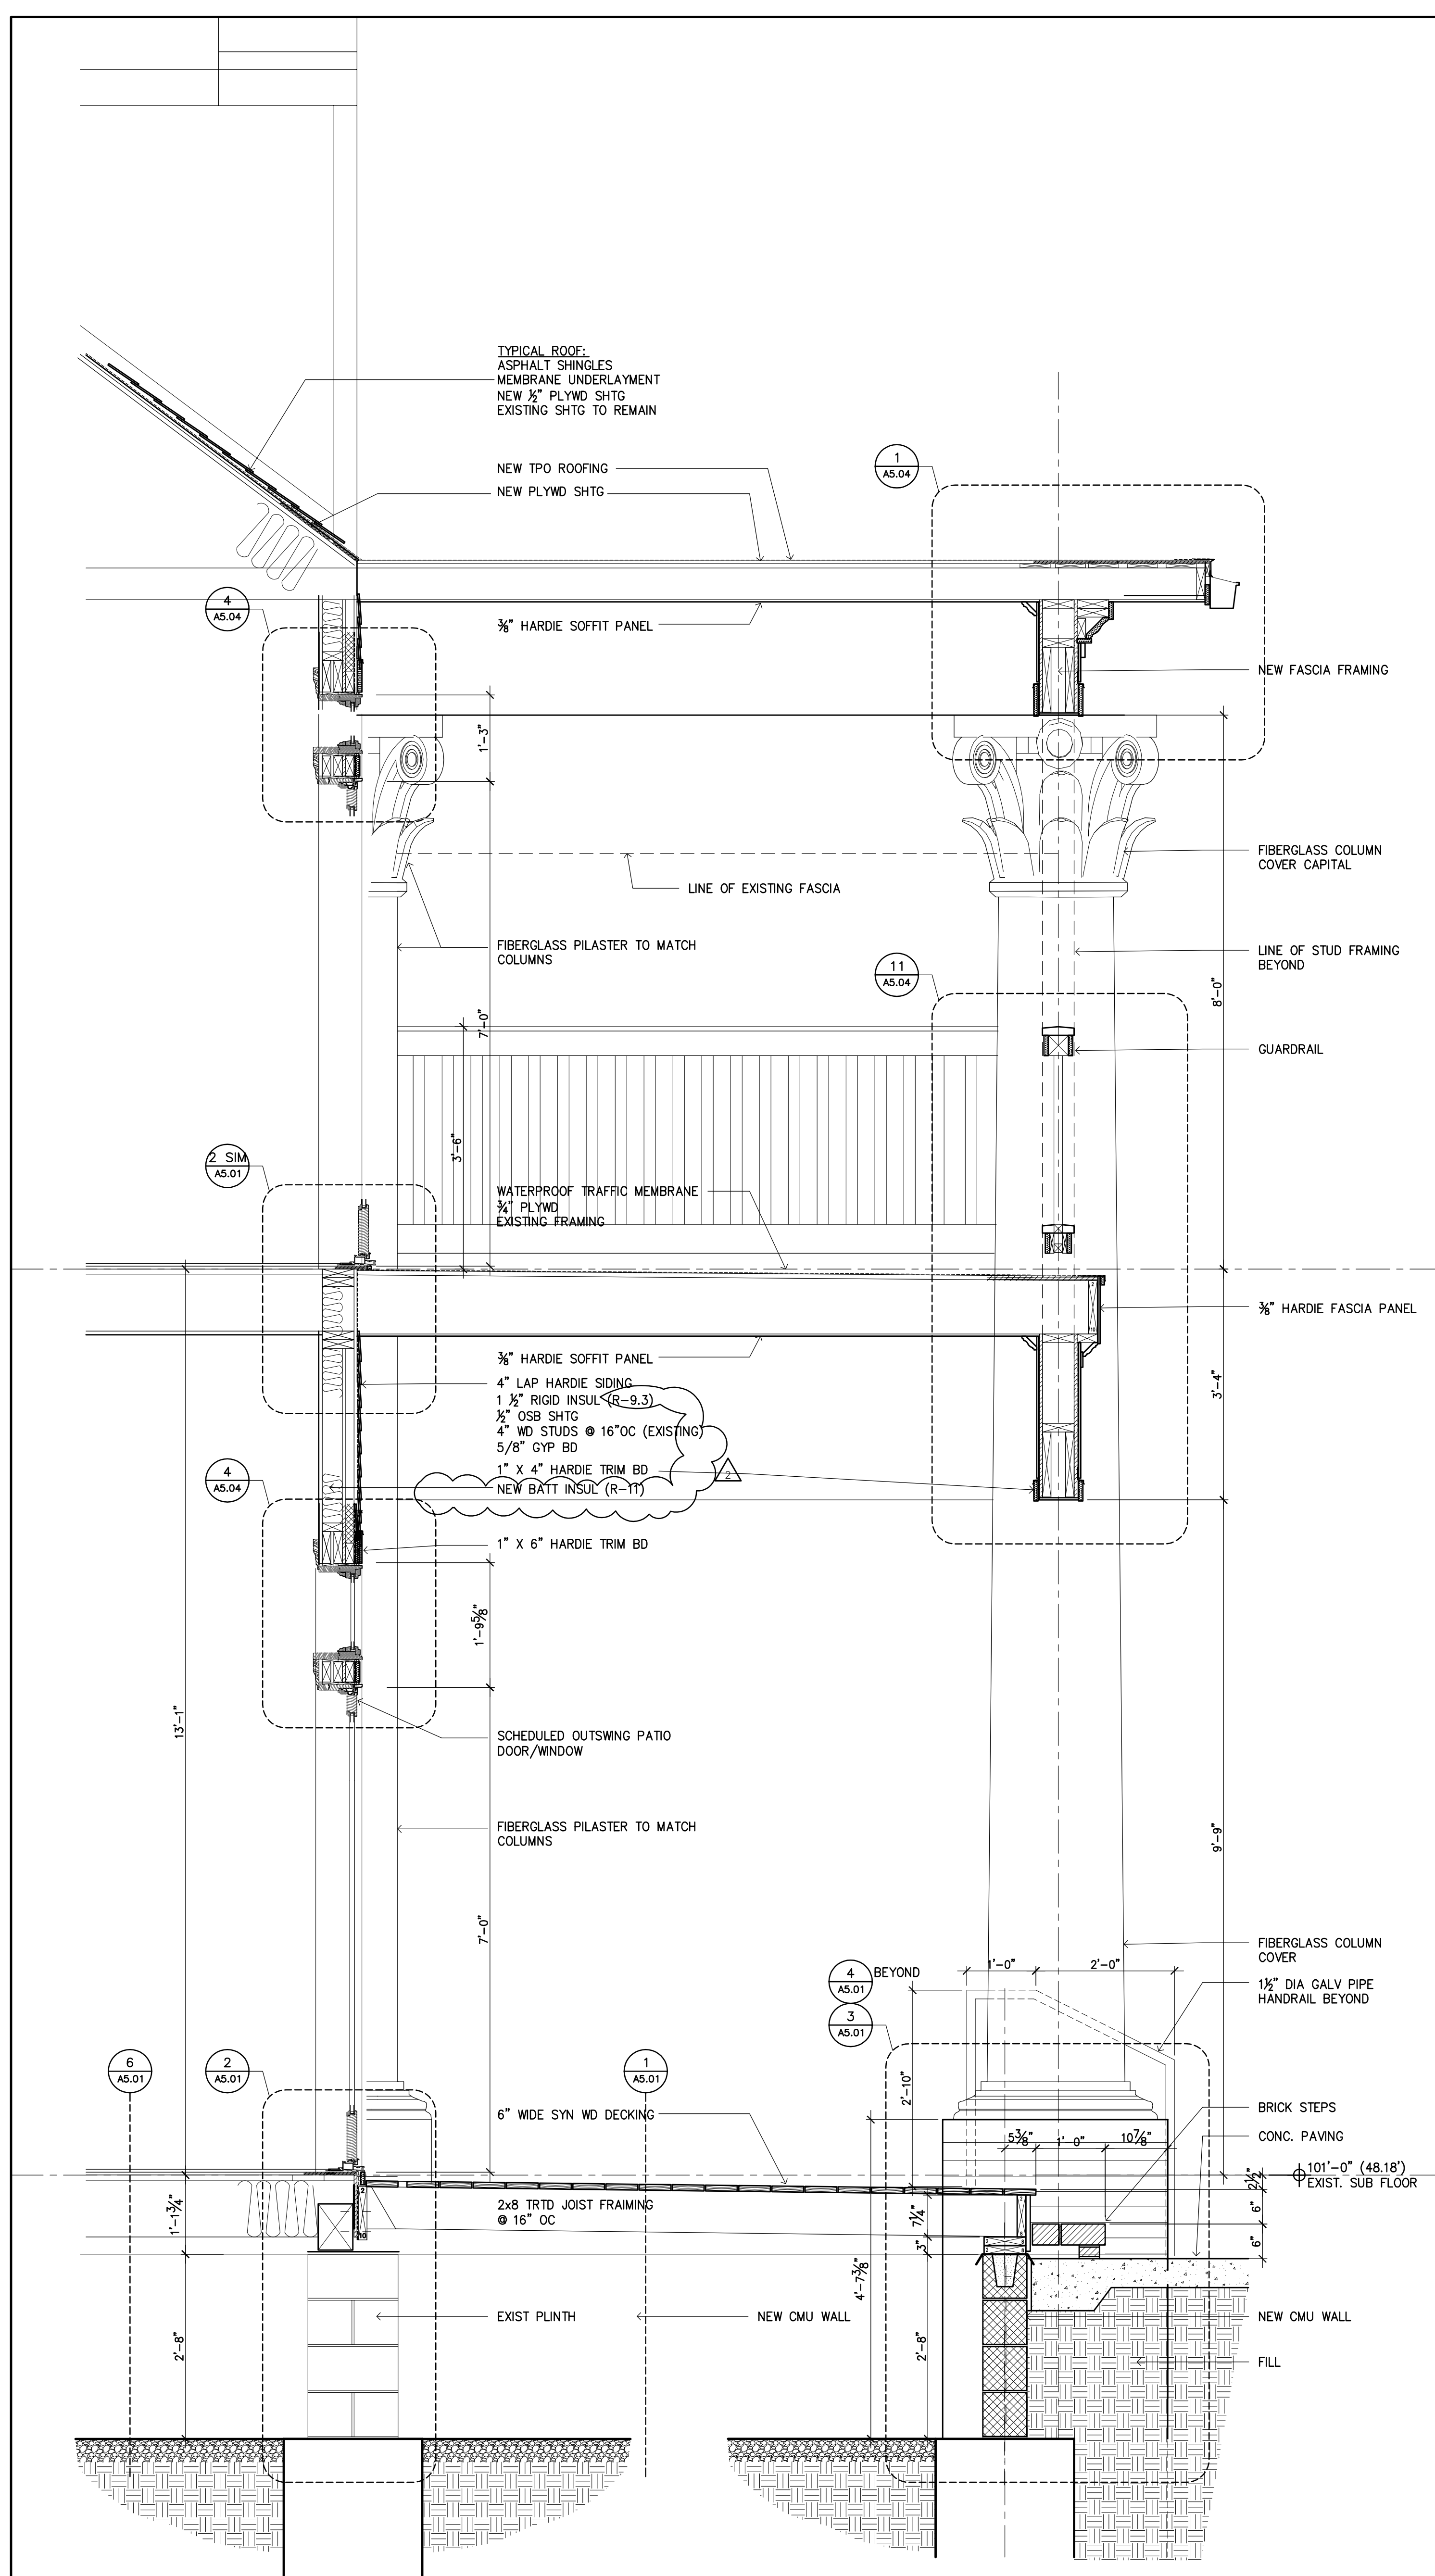


1 WALL SECTION
SCALE: 3/4"=1'-0"

2 WALL SECTION
SCALE: 3/4"=1'-0"

3 WALL SECTION
SCALE: 3/4"=1'-0"

4 WALL SECTION
SCALE: 3/4"=1'-0"

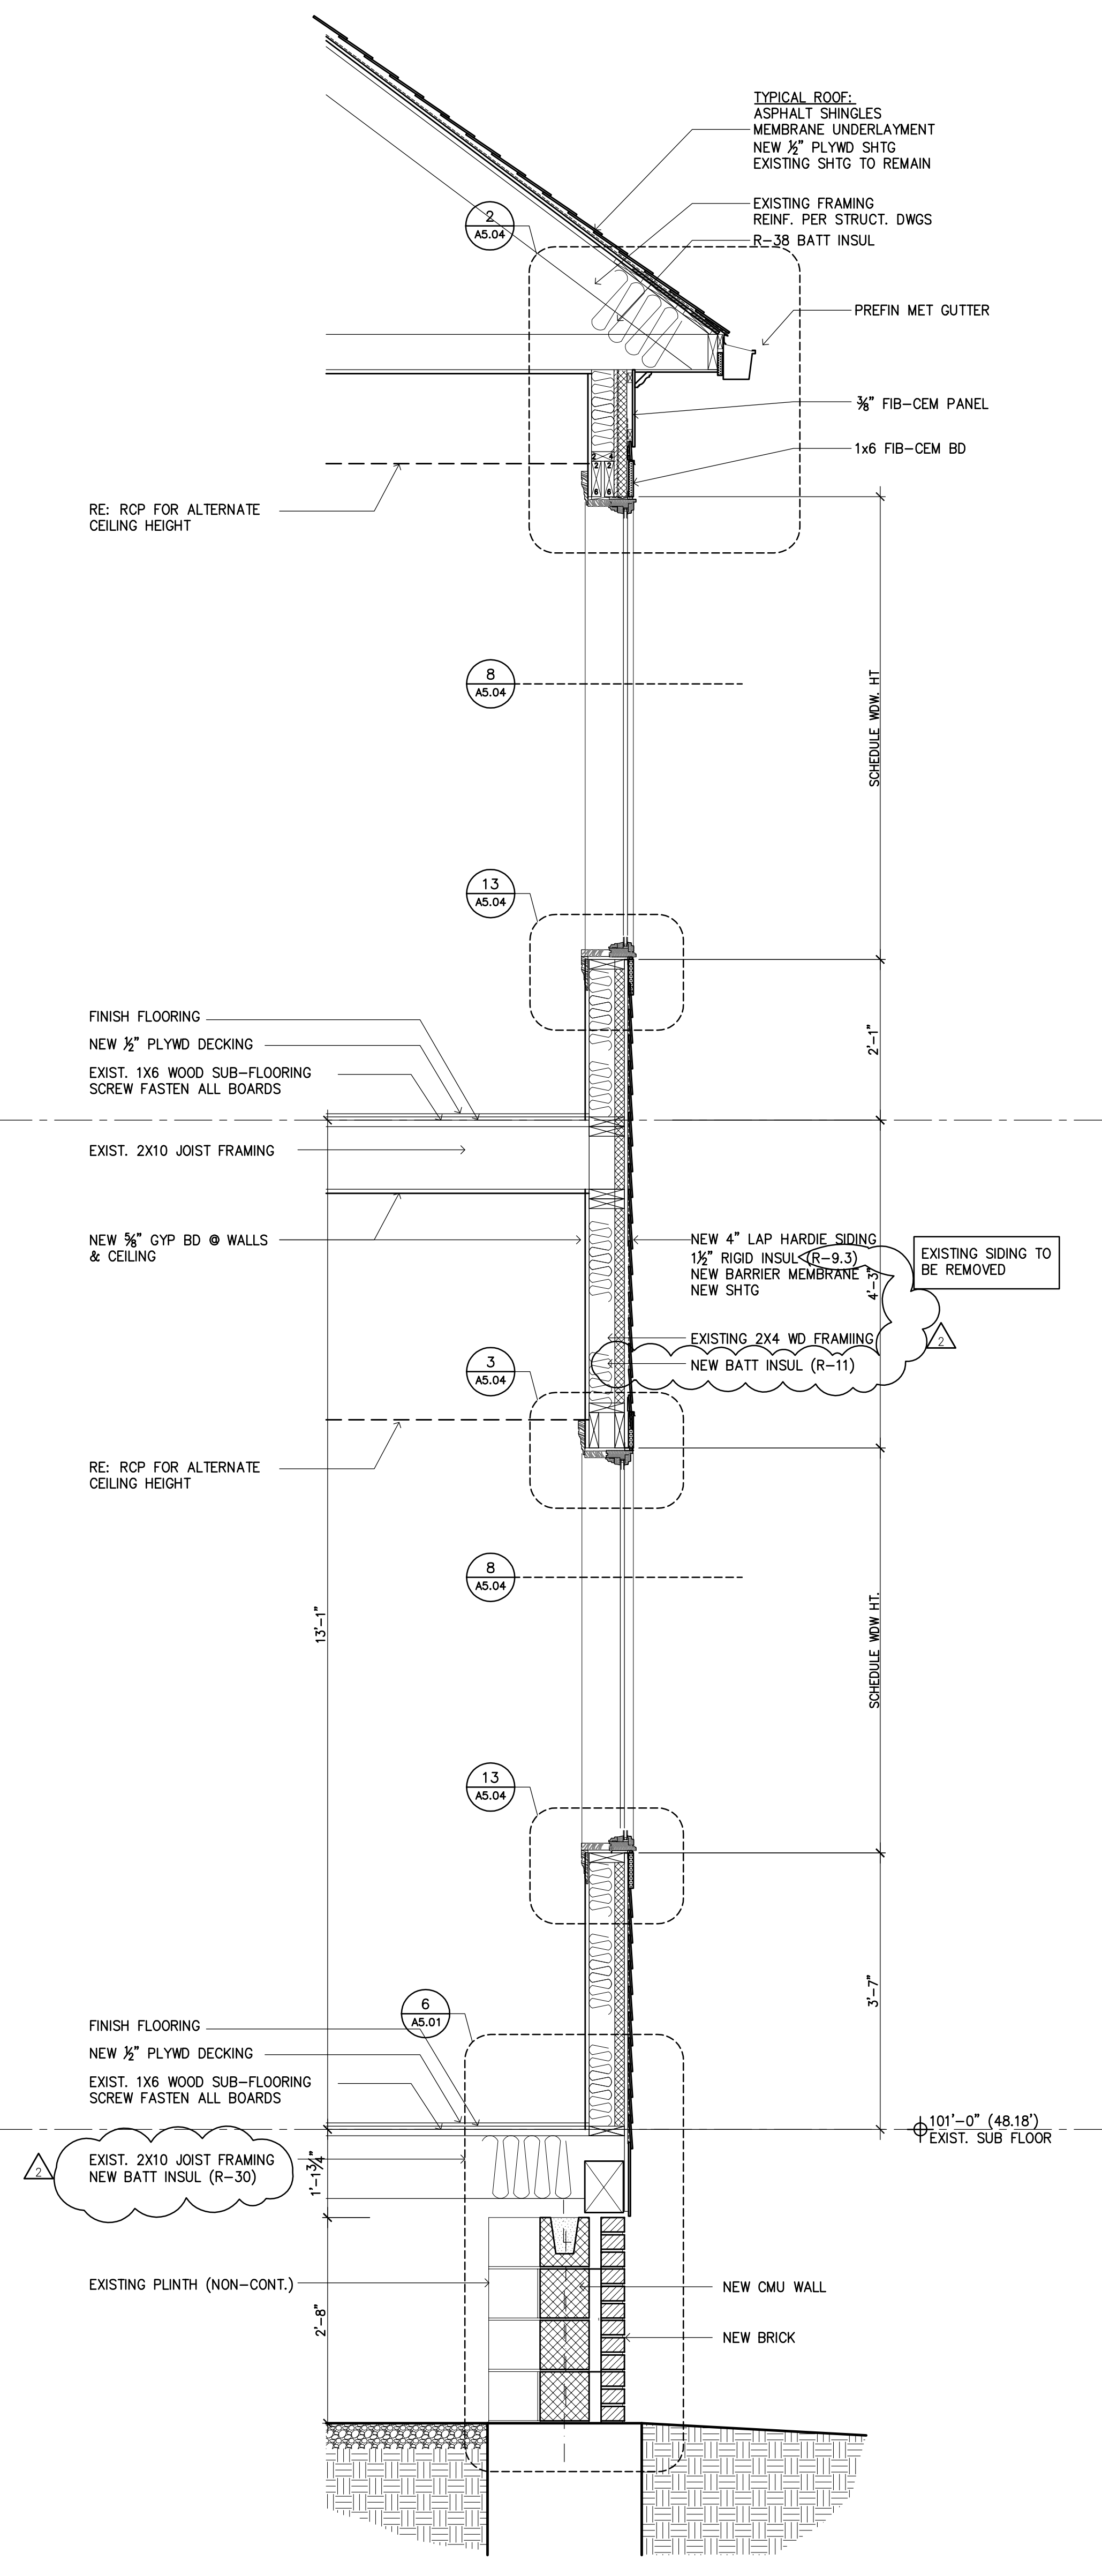

5 WALL SECTION
SCALE: 3/4"=1'-0"

ISSUES

NO.	DATE	DESCRIPTION
1/27/2017	50% CD REVIEW	
3/6/2017	ISSUED FOR PERMIT	
6/30/2017	100% CD REVIEW	
7/14/2017	ISSUED FOR PERMIT	

REVISIONS

NO.	DATE	DESCRIPTION
9/15/2017	PERMIT COMMENTS	
10/20/2017	PERMIT COMMENTS	



**ANNUNCIATION
CATHOLIC CHURCH
FOLEY HOUSE RENOVATION
RECTORY AND RESTROOM
ADDITION**

**SHEET TITLE
WALL SECTIONS
FOLEY HOUSE**

SHEET NUMBER
A3.24