


APPROVED ELECTRICAL PLAN
PLANS AND SPECIFICATIONS TO BE IN ACCORDANCE WITH CURRENT NATIONAL ELECT. CODE & CITY BUILDING CODE. THIS PLAN SHALL BE KEPT ON JOB FOR INSPECTOR'S SEPARATE PERMIT FOR ELECTRICAL REQUIRED.
NO. 385

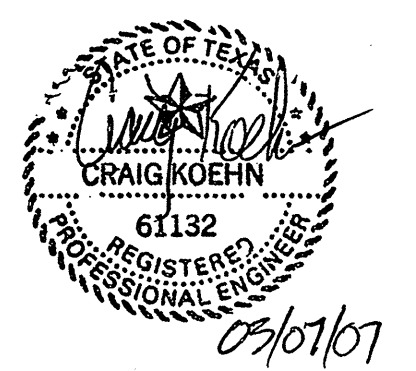


ELECTRICAL POWER GENERAL NOTES:

- MEP SPECIFICATIONS SHALL APPLY TO ALL WORK ON THIS DRAWING UNLESS OTHERWISE NOTED.
- MOUNT ALL WALL OUTLETS AT 18" AFF TO CENTERLINE OF BOX UNLESS NOTED OTHERWISE. ALL OUTLETS DESIGNATED AS "+42" TO BE MOUNTED AT 42" TO BOTTOM OF BOX.
- DATA/TELEPHONE CABLE IN RETURN AIR PLENUM SHALL BE PLENUM RATED OR INSTALLED IN CONDUIT. ALL DATA/TELEPHONE OUTLETS SHALL BE PROVIDED WITH PULL STRINGS.
- CONTRACTOR SHALL LOCATE ALL ELECTRICAL & TELEPHONE OUTLETS WITHIN THE LIMITS OF THE TENANT FURNITURE PLAN PROVIDED BY THE ARCHITECT. CONTRACTOR SHALL MARK INTENDED LOCATION OF ALL OUTLETS PRIOR TO INSTALLATION, THEN SHALL NOTIFY TENANT FOR APPROVAL BEFORE PROCEEDING.

- CONTRACTOR SHALL PROVIDE NEW CIRCUIT DIRECTORY CARD AT PANELS. CIRCUITS SHALL BE LABELED TO CORRESPOND TO THE CIRCUITS SHOWN ON THE DRAWINGS. CONTRACTOR SHALL CONNECT CIRCUITS AS REQUIRED TO COMPLY WITH THIS DRAWING.
- CONDUCTORS SHALL BE #12 AWG SOLID COPPER (THWN) IN 1/2" CONDUIT UNLESS OTHERWISE INDICATED.
- ALL OUTLETS TO BE MOUNTED VERTICALLY UNLESS OTHERWISE INDICATED.
- CONTRACTOR SHALL PROVIDE ONE PULL STRING FOR EACH VOICE OR DATA OUTLET SHOWN. WHEN VOICE AND DATA OUTLETS ARE SHOWN ADJACENT, CONTRACTOR SHALL PROVIDE ONE PULL STRING (WITH ONE WALL PENETRATION) FOR THE PAIR, UNLESS NOTED OTHERWISE. VOICE AND DATA LINES SHALL BE PULLED BY OTHERS.

ELECTRICAL POWER KEYED NOTES:

- PROVIDE (2) DUPLEX RECEPTACLES UNDER A COMMON COVERPLATE. PROVIDE FOR (1) GENERAL PURPOSE CIRCUIT AND (1) PC CIRCUIT. UNLESS NOTED OTHERWISE ON THE ARCHITECT'S DRAWINGS, PC DEVICE TO BE GREY.
- VERIFY LOCATION OF ALL RECEPTACLES IN THIS ROOM PRIOR TO INSTALLATION.
- PROVIDE WIREMOLD 881 SERIES PVC FLOOR BOX AND 881 SERIES FLOOR BOX COVER KIT WITH (2) DUPLEX RECEPTACLES AND (4) VOICE/DATA OUTLETS. VERIFY FINISH WITH ARCHITECT PRIOR TO INSTALLATION.
- PROVIDE JUNCTION BOX IN WALL FOR POWER TO ELECTRIC HAND DRYER.
- PROVIDE JUNCTION BOX IN WALL FOR POWER TO ELECTRIC DRINKING FOUNTAIN.
- PROVIDE RECEPTACLE MOUNTED TO UNIT FOR MAINTENANCE. REFER TO DETAIL FOR MORE INFORMATION.
- PROVIDE JUNCTION BOX IN WALL FOR POWER TO SCOREBOARD. VERIFY LOCATION WITH ARCHITECT PRIOR TO INSTALLATION.

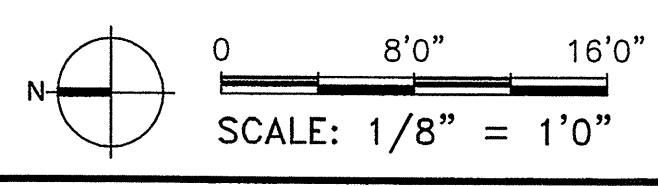

E/B/E, Inc.
ELECTRICAL/MECHANICAL CONSULTING ENGINEERS
Firm Registration No: 5638
Tel: (713) 840-0177
Fax: (713) 840-8677

ELECTRICAL POWER PLAN

ISSUES & REVISIONS	
08/07/06	BID AND PERMIT
03/07/07	PERMIT COMMENTS

SHEET TITLE
ELECTRICAL POWER PLAN

PROJECT NO. 06120.00
SCALE AS NOTED

SHEET NUMBER
E02.02